


STATE OF FLORIDA
 DEPARTMENT OF TRANSPORTATION
CONTRACT PLANS

FINANCIAL PROJECT ID 415490-1-52-01
 (FEDERAL FUNDS)
 DESOTO COUNTY (04020)
 STATE ROAD NO. 35 (U.S. 17)

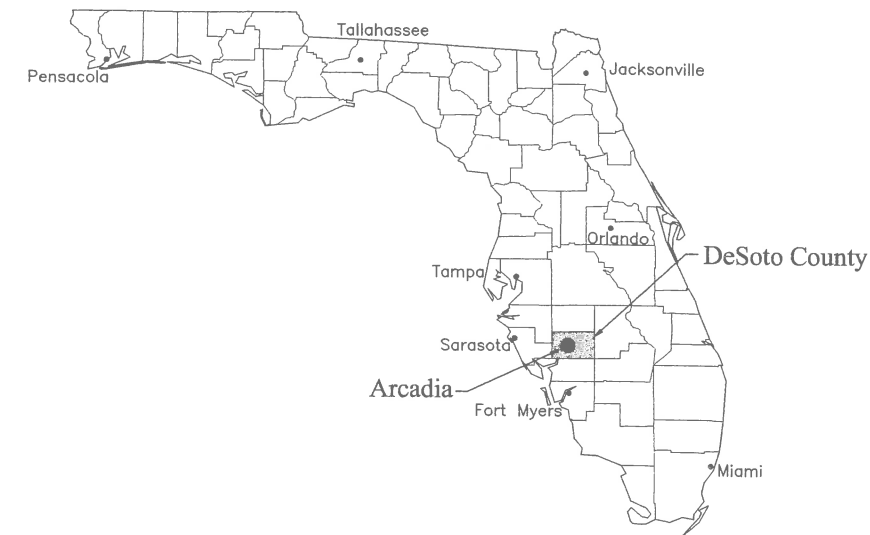


LIST OF DRAWINGS

SHEET	CONTENT
1	COVER SHEET
2	GENERAL NOTES
3-4	PAY ITEMS
5-33	PLAN AND PROFILE

GOVERNING STANDARDS AND SPECIFICATIONS:
 FLORIDA DEPARTMENT OF TRANSPORTATION,
 DESIGN STANDARDS DATED 2006,
 AND STANDARD SPECIFICATIONS FOR ROAD AND
 BRIDGE CONSTRUCTION DATED 2007,
 AS AMENDED BY CONTRACT DOCUMENTS.

APPLICABLE DESIGN STANDARDS MODIFICATIONS: 7-1-10
 "For Design Standards Modifications click on
 "Design Standards" at the following web site:
<http://www.dot.state.fl.us/design/>

REVISIONS:

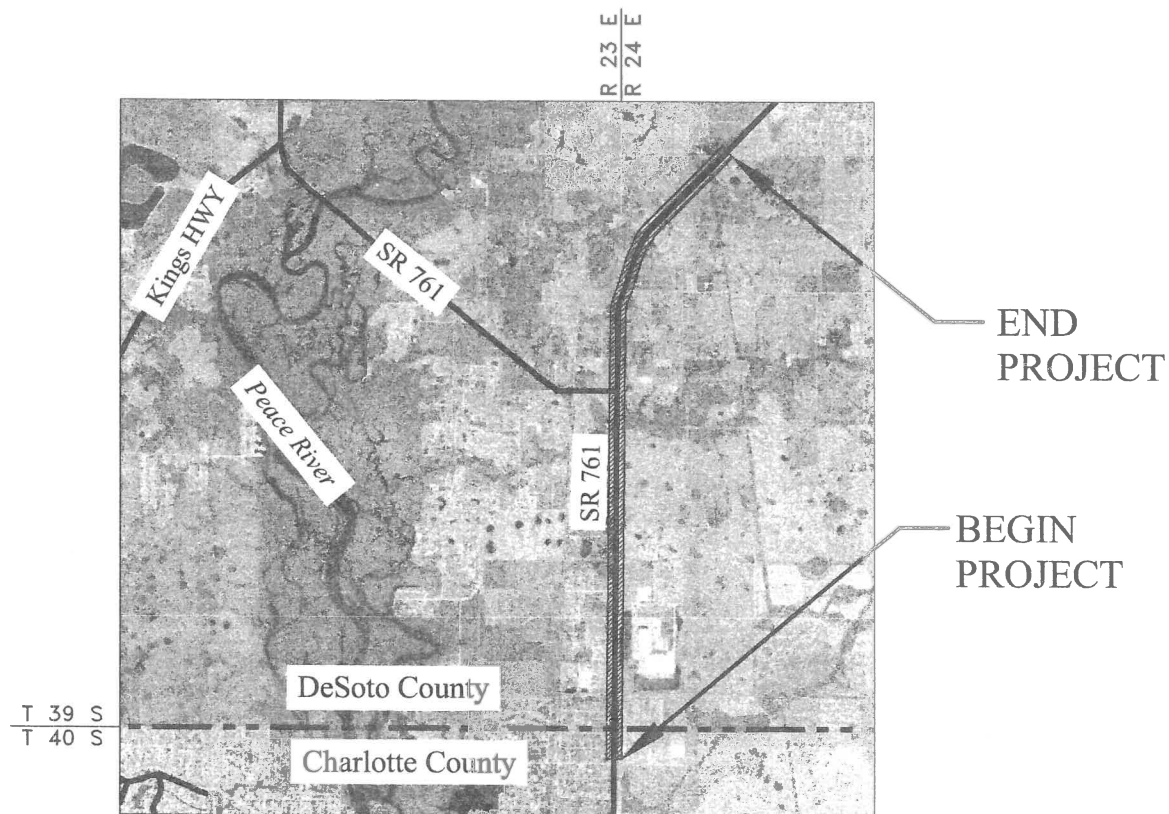

LOCATION MAP
 NOT TO SCALE



PREPARED BY


BASKERVILLE-DONOVAN, INC.
 INNOVATIVE INFRASTRUCTURE SOLUTIONS
 6000 CATTLEBRIDGE DRIVE, SUITE 300
 SARASOTA, FL 34232
 (941)316-0411

BDI Project No. 11303.01
 JUNE, 2008

75% SUBMITTAL

FISCAL YEAR	SHEET NO.
II	1

T:\EC\US17\Project Layout.dwg, Jun 30, 2008 - 11:59:58AM, egackic

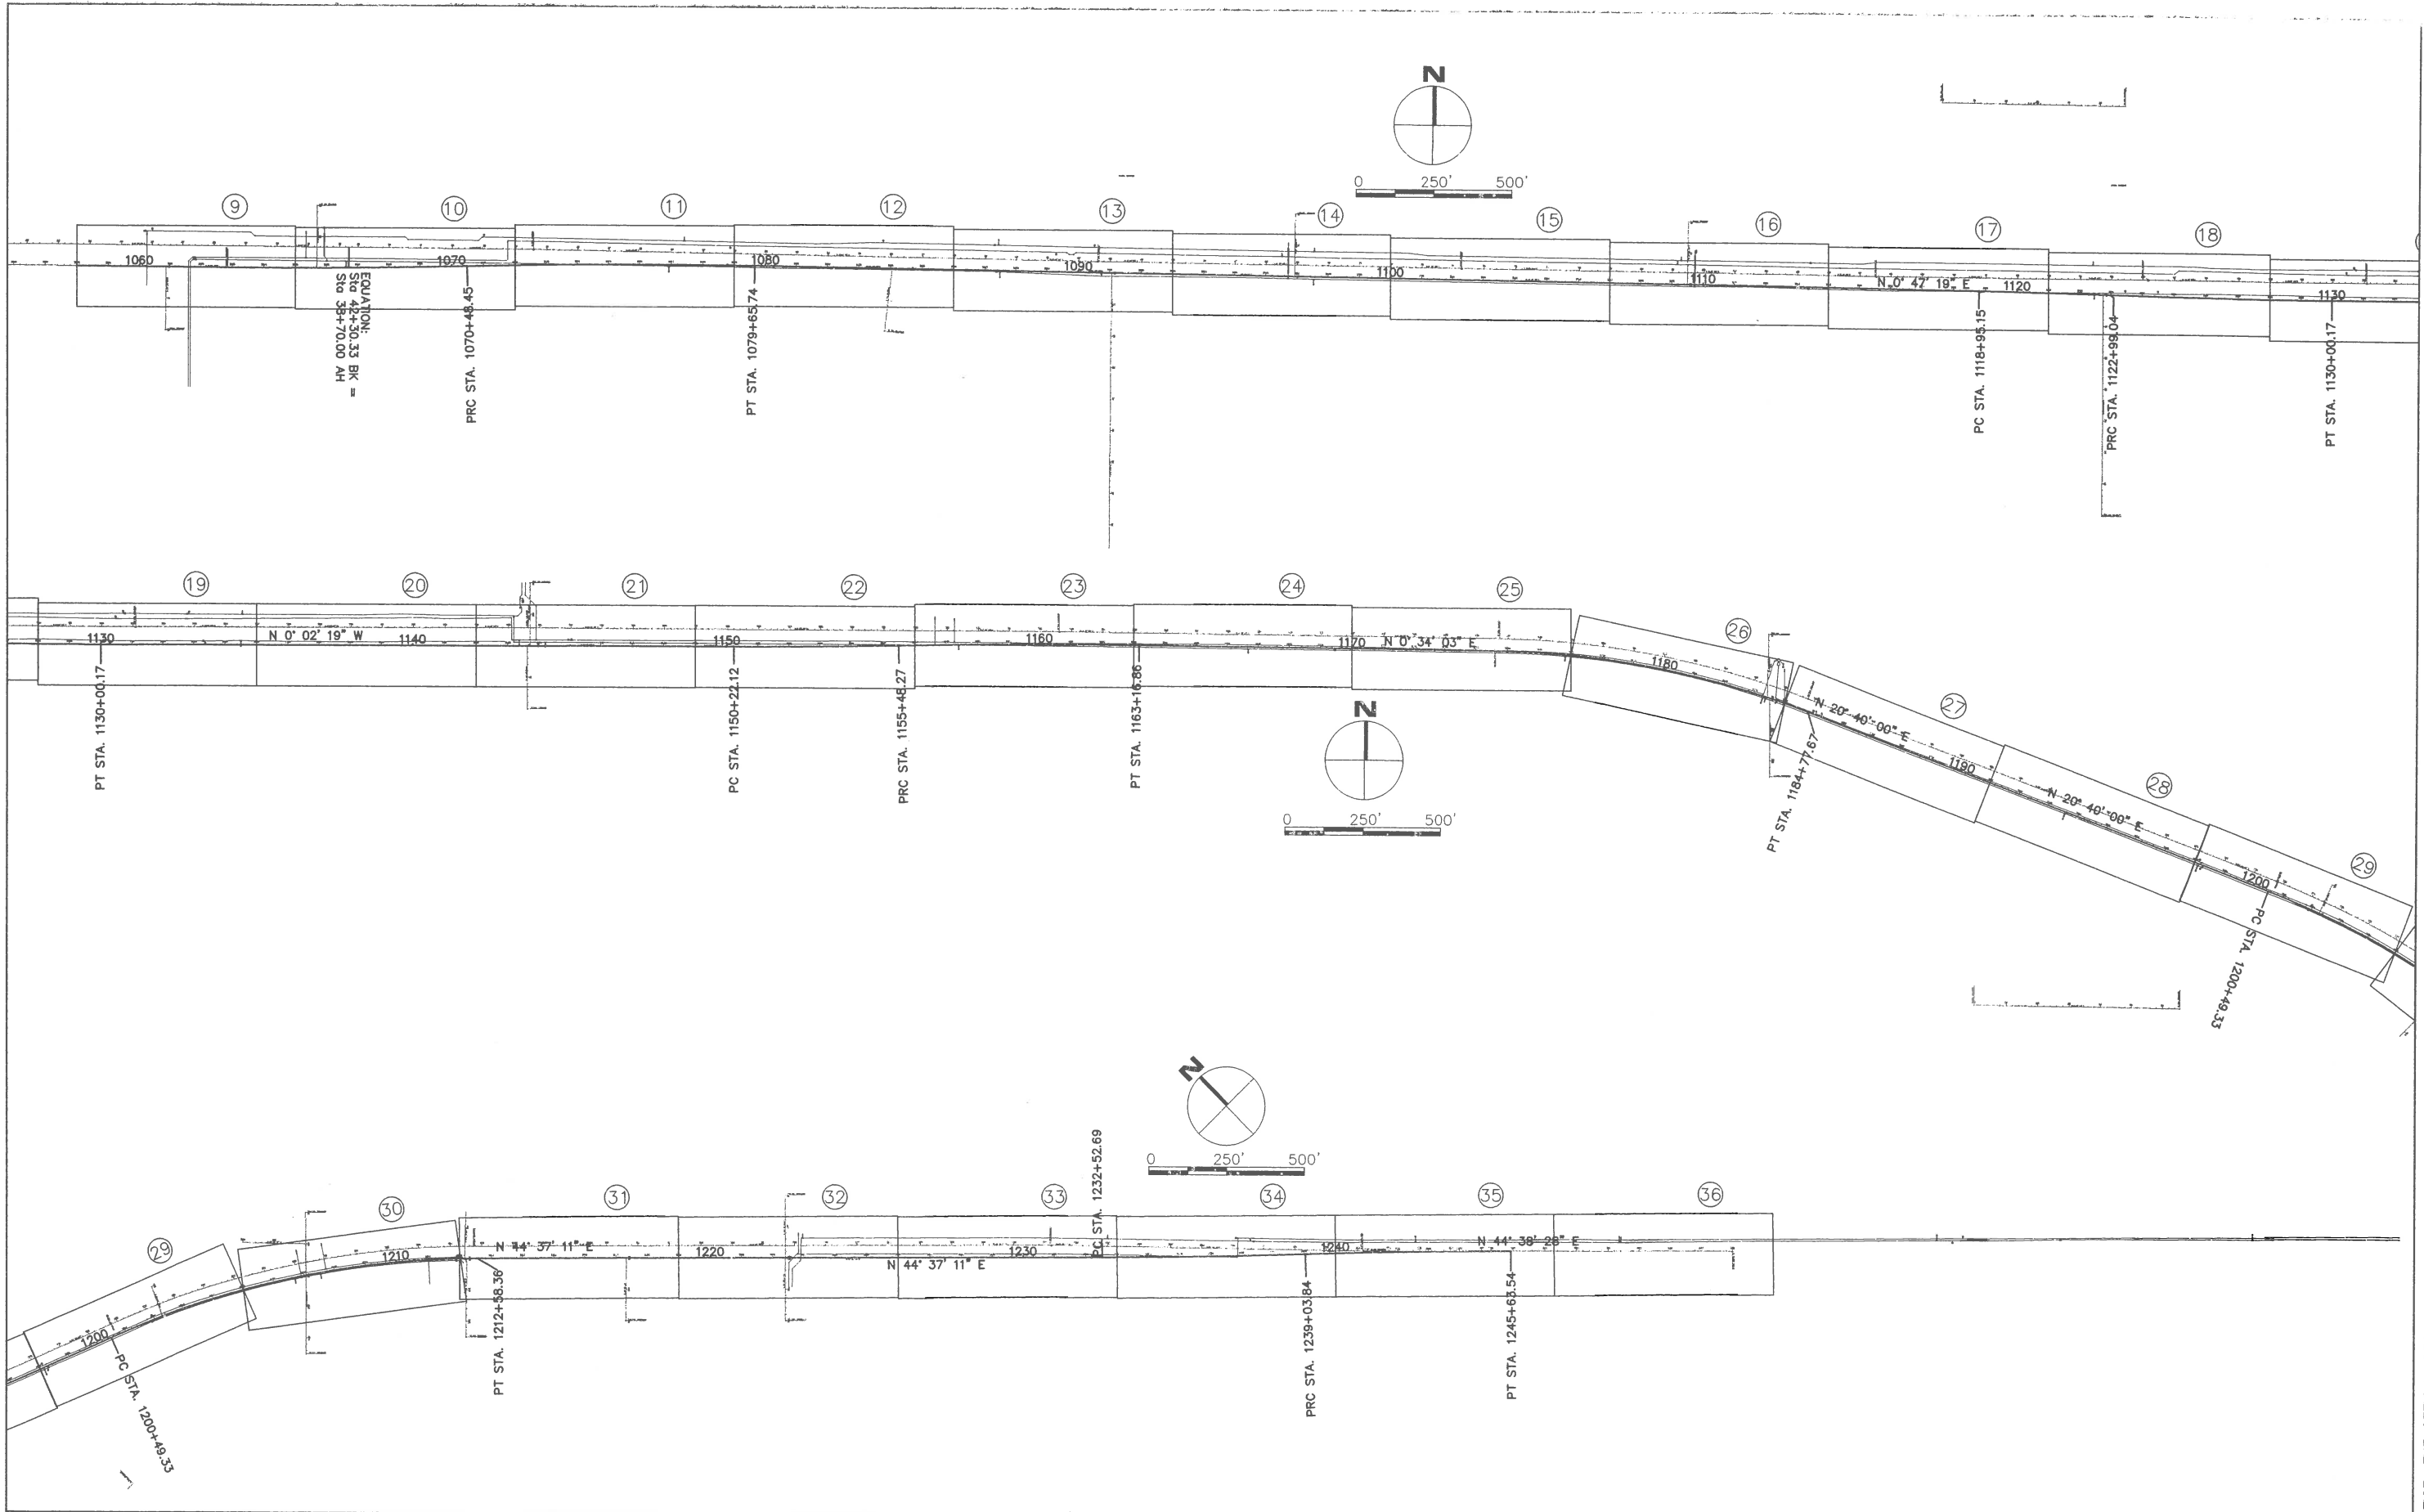

EQUATION:
Sta 42+30.33 BK =
Sta 38+70.00 AH

REVISIONS					
DATE	BY	DESCRIPTION	DATE	BY	DESCRIPTION

B BASKERVILLE-DONOVAN, INC.
INNOVATIVE INFRASTRUCTURE SOLUTIONS
6000 CATTLEBRIDGE DRIVE, SUITE 300
SARASOTA, FLORIDA 34232
CERT. OF AUTH.: EB-0000340

WAYNE E. WHITE, P.E.
P.E. LICENSE NO. 53232


STATE OF FLORIDA DEPARTMENT OF TRANSPORTATION		
ROAD NO.	COUNTY	FINANCIAL PROJECT ID
SR 35	DESOTO	415490-1-52-01

PROJECT LAYOUT

SHEET NO.
2

NOTICE: THE OFFICIAL RECORD OF THIS SHEET IS THE ELECTRONIC FILE SIGNED AND SEALED UNDER RULE 61G15-23.003, F.A.C.

Pay Item #	Item Description	Unit	Total
Pipes			
1050 11223	Utility pipe, F&I, PVC, Water/Sewer, 5 - 7.9"	LF	0.00
1050 11224	Utility pipe, F&I, PVC, Water/Sewer, 8 - 19.9"	LF	6,290.09
1050 11424	Utility pipe, F&I, DI/CI, Water/Sewer, 8 - 19.9"	LF	0.00
1050 14004	Utility pipe, Relocate, 8-19.9"	LF	781.34
1050 16004	Utility pipe, Remove/Dispose, 8-19.9"	LF	1,001.07
1050 17004	Utility pipe, Remove & Stockpile/Salvage, 8-19.9"	LF	
Fittings			
1055 11214	Utility fittings, F&I, PVC, Elbow, 8 - 19.9"	EA	31
1055 11224	Utility fittings, F&I, PVC, Tee, 8 - 19.9" (& cross)	EA	48
1055 11234	Utility fittings, F&I, PVC, Reducer, 8 - 19.9"	EA	15
1055 11244	Utility fittings, F&I, PVC, Union, 8 - 19.9"	EA	
1055 11254	Utility fittings, F&I, PVC, Cap/Plug, 8 - 19.9"	EA	55
1055 11264	Utility fittings, F&I, PVC, Y fitting, 8 - 19.9"	EA	
Fixtures			
1080 11401	Utility fixtures, F&I, PVC, 8 - 19.9", Valve Meter Box	EA	
1080 11402	Utility fixtures, F&I, PVC, 8 - 19.9", Backflow assembly	EA	
1080 11403	Utility fixtures, F&I, PVC, 8 - 19.9", Tapping saddle/sleeve	EA	
1080 11404	Utility fixtures, F&I, PVC, 8 - 19.9", Valve Assembly	EA	38
1080 11405	Utility fixtures, F&I, PVC, 8 - 19.9", Blowoff Assembly	EA	
1080 11406	Utility fixtures, F&I, PVC, 8 - 19.9", Vac/Air Assembly	EA	
1080 14	Utility fixtures, Relocate	EA	12
1080 16401	Utility fixtures, Remove & Dispose, 8-19.9", Valve/Meter	EA	3
1080 17	Utility fixtures, Remove, Stockpile, Salvage	EA	
1644113 08	Fire Hydrant, F&I, Standard, 2 Hose, 1Pumper, 6"	EA	0
1644800	Fire Hydrant, Relocate	EA	13

REVISIONS						 BASKERVILLE-DONOVAN, INC. INNOVATIVE INFRASTRUCTURE SOLUTIONS 6000 CATTLEBRIDGE DRIVE, SUITE 300 SARASOTA, FLORIDA 34232 CERT. OF AUTH.: EB-0000340	STATE OF FLORIDA DEPARTMENT OF TRANSPORTATION			WATERMAIN PAY ITEM	SHEET NO. 3
DATE	BY	DESCRIPTION	DATE	BY	DESCRIPTION		ROAD NO.	COUNTY	FINANCIAL PROJECT ID		
						SR 35	DESOTO	415490-1-52-01			
						WAYNE E. WHITE, P.E. P.E. LICENSE NO. 53232					

NOTICE: THE OFFICIAL RECORD OF THIS SHEET IS THE ELECTRONIC FILE SIGNED AND SEALED UNDER RULE 61G15-23.003, F.A.C.

**SR35 (US17) - DeSoto County, Florida
-Addition to project scope-**





0 500 1,000 2,000 3,000 Feet

0 0.1 0.2 0.3 0.4 0.5 Miles

Legend:

- Alignment 6,000 ft (Sta. 1000+00 - 1060+00)
- █ Project scope 14,000 ft (Sta. 1060+00 - 1200+00)
- █ Addition to project scope 5,270 ft (Sta. 1200+00 - 1252+70)

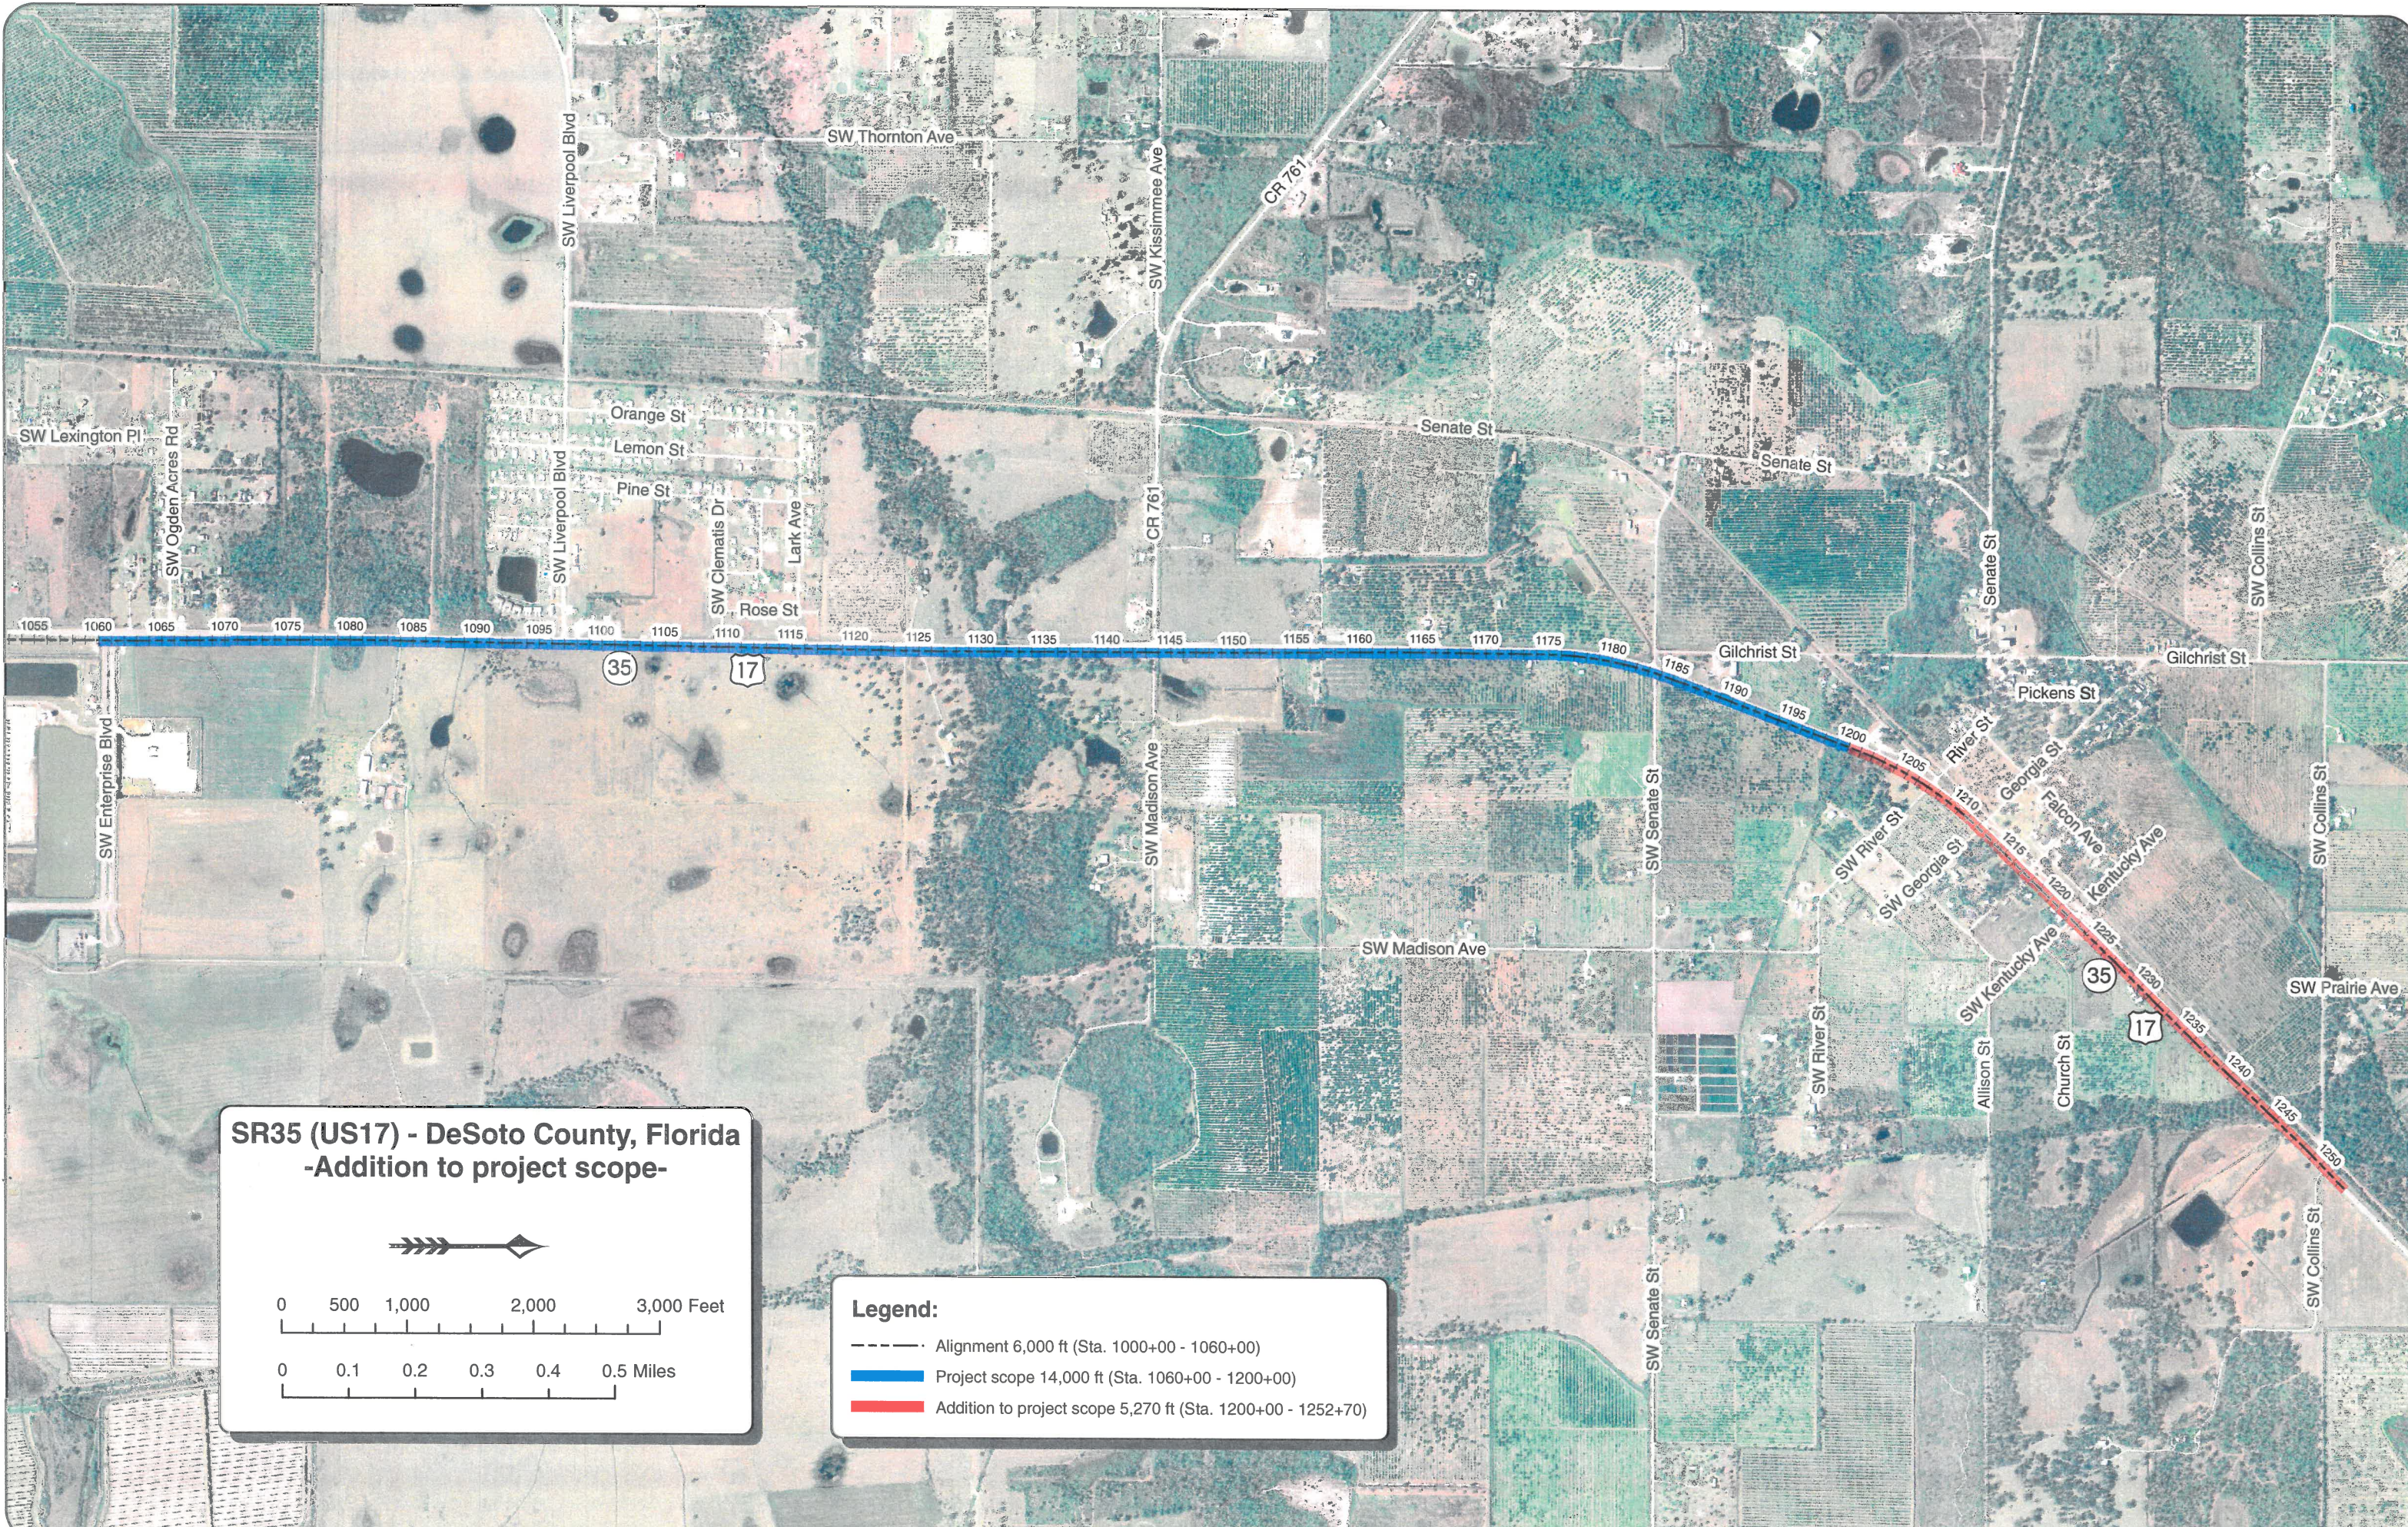

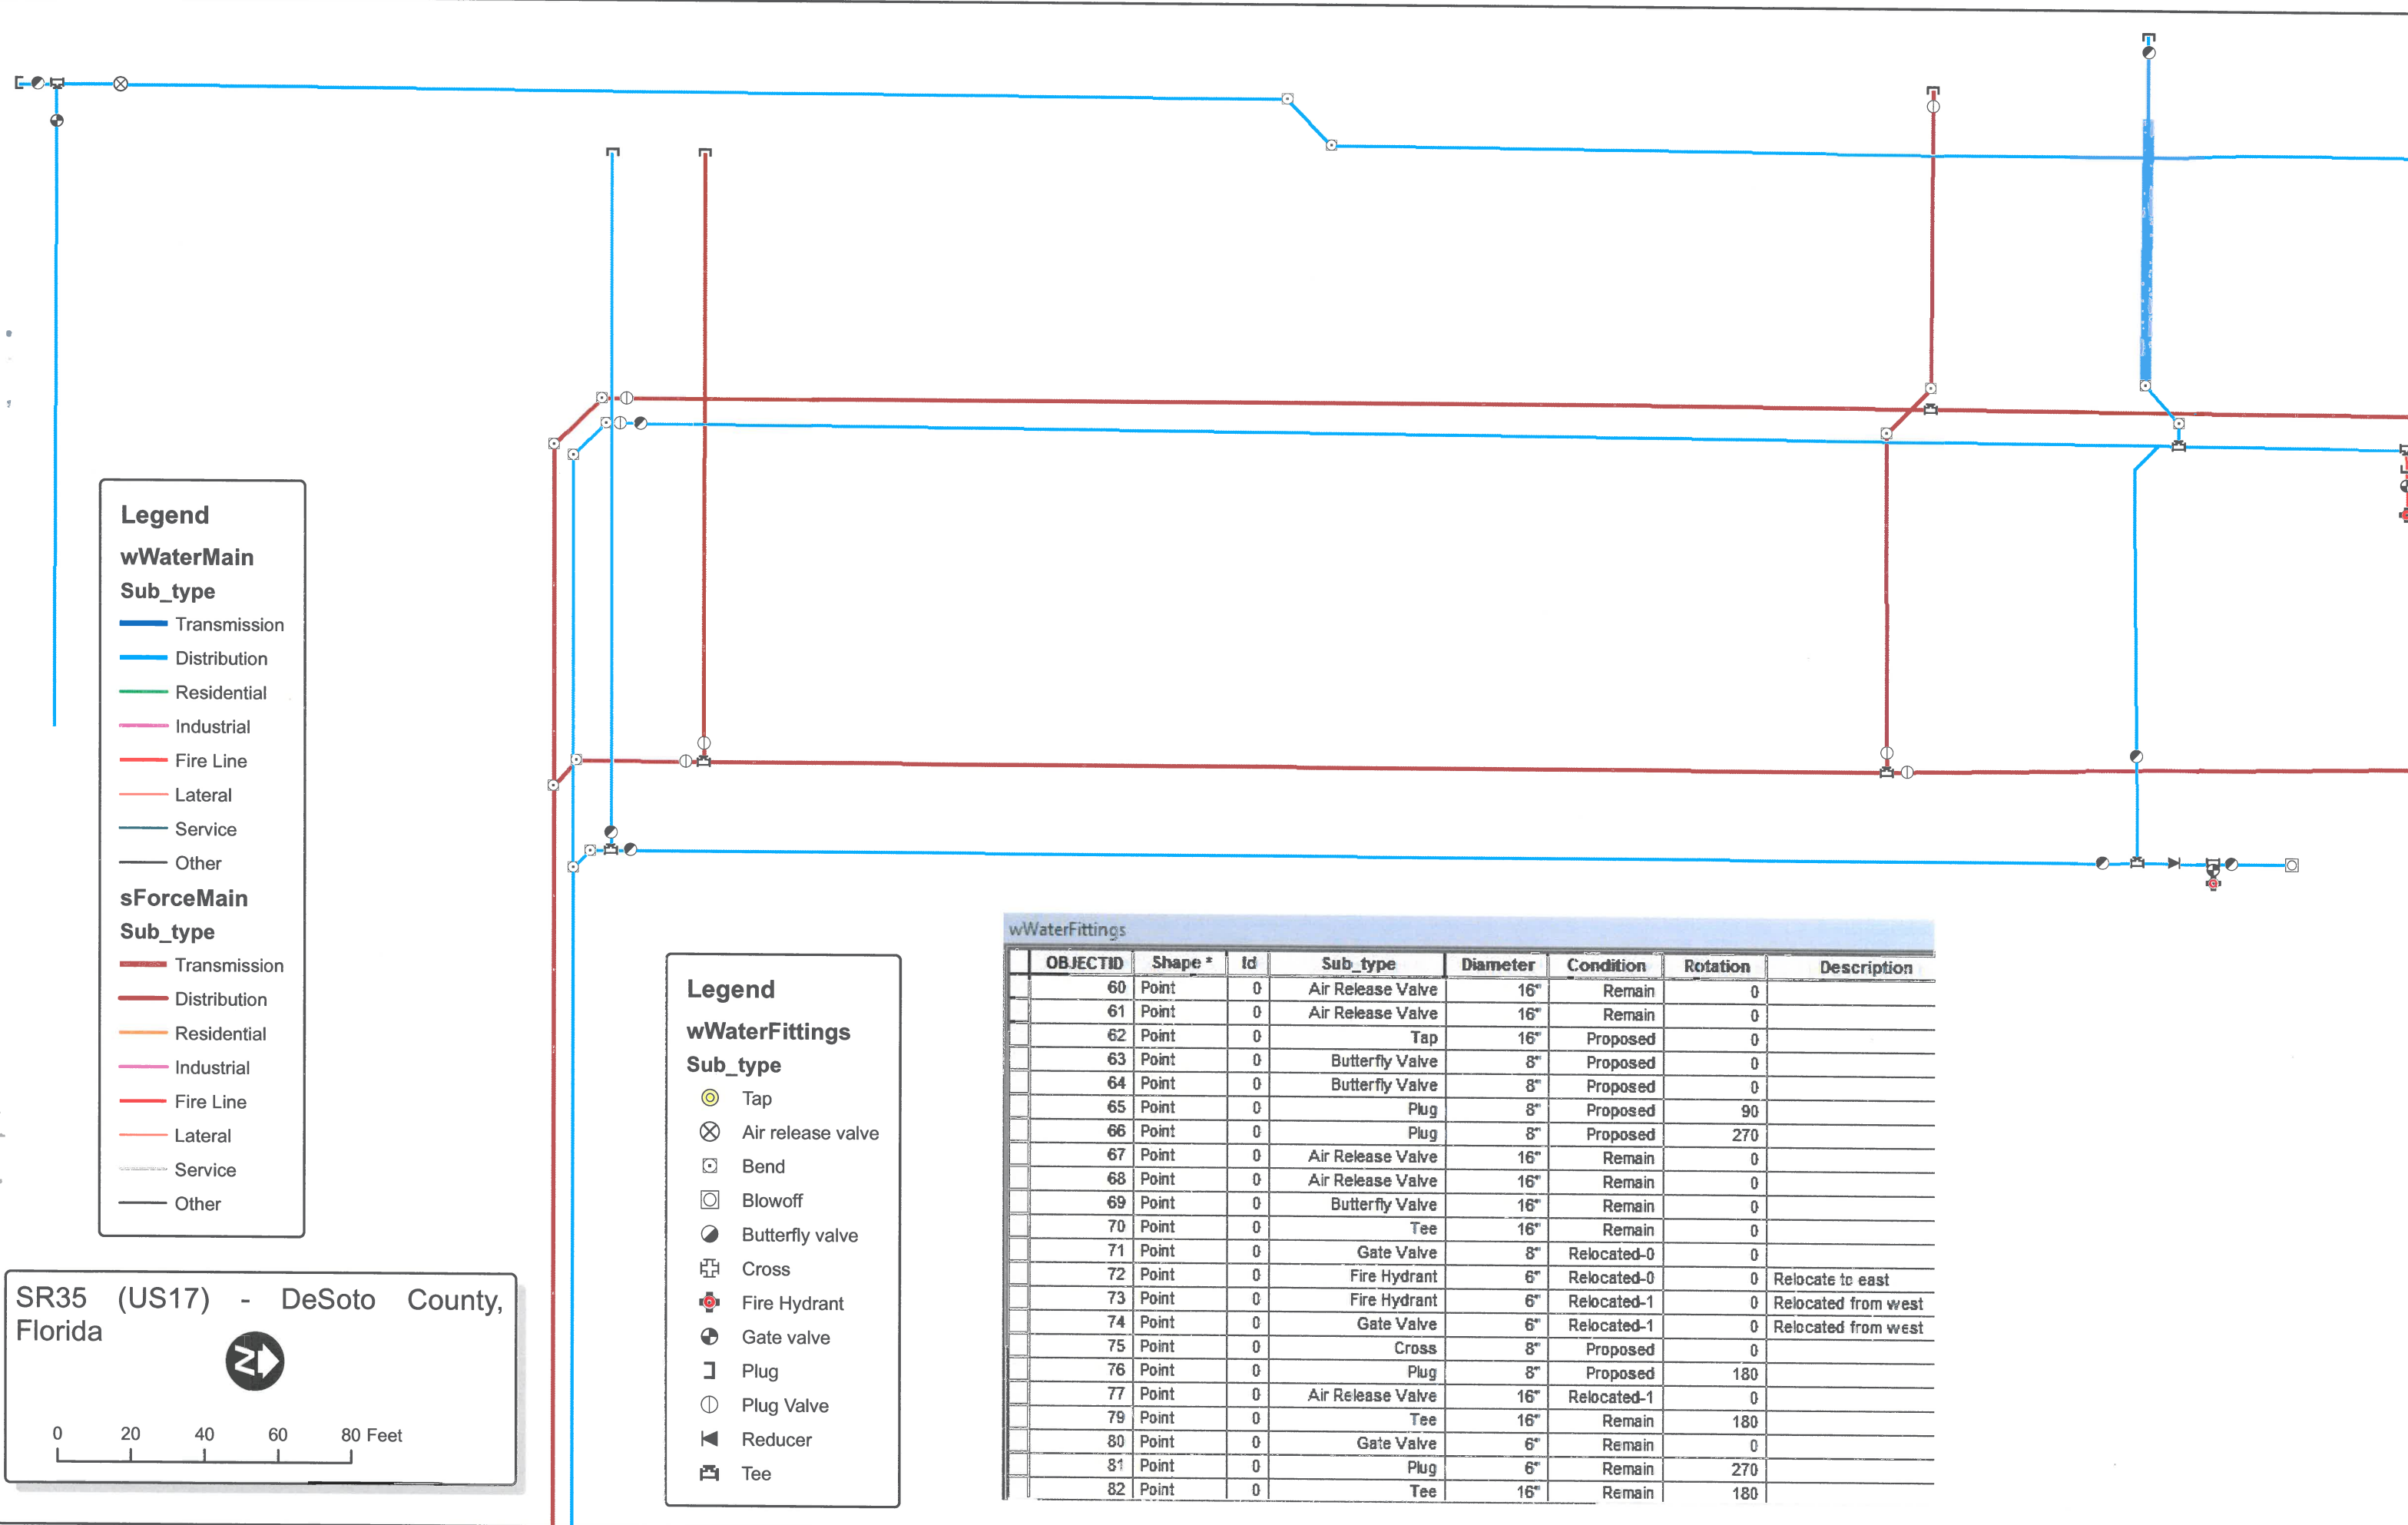

Legend

wWaterMain

Sub_type

- Transmission
- Distribution
- Residential
- Industrial
- Fire Line
- Lateral
- Service
- Other

sForceMain

Sub_type

- Transmission
- Distribution
- Residential
- Industrial
- Fire Line
- Lateral
- Service
- Other

Legend

wWaterFittings

Sub_type

- Tap
- Air release valve
- Bend
- Blowoff
- Butterfly valve
- Cross
- Fire Hydrant
- Gate valve
- Plug
- Plug Valve
- Reducer
- Tee

OBJECTID	Shape *	Id	Sub_type	Diameter	Condition	Rotation	Description
60	Point	0	Air Release Valve	16"	Remain	0	
61	Point	0	Air Release Valve	16"	Remain	0	
62	Point	0	Tap	16"	Proposed	0	
63	Point	0	Butterfly Valve	8"	Proposed	0	
64	Point	0	Butterfly Valve	8"	Proposed	0	
65	Point	0	Plug	8"	Proposed	90	
66	Point	0	Plug	8"	Proposed	270	
67	Point	0	Air Release Valve	16"	Remain	0	
68	Point	0	Air Release Valve	16"	Remain	0	
69	Point	0	Butterfly Valve	16"	Remain	0	
70	Point	0	Tee	16"	Remain	0	
71	Point	0	Gate Valve	8"	Relocated-0	0	
72	Point	0	Fire Hydrant	6"	Relocated-0	0	Relocate to east
73	Point	0	Fire Hydrant	6"	Relocated-1	0	Relocated from west
74	Point	0	Gate Valve	6"	Relocated-1	0	Relocated from west
75	Point	0	Cross	8"	Proposed	0	
76	Point	0	Plug	8"	Proposed	180	
77	Point	0	Air Release Valve	16"	Relocated-1	0	
79	Point	0	Tee	16"	Remain	180	
80	Point	0	Gate Valve	6"	Remain	0	
81	Point	0	Plug	6"	Remain	270	
82	Point	0	Tee	16"	Remain	180	

SR35 (US17) - DeSoto County, Florida

0 20 40 60 80 Feet